


SPACE SCHEDULE		
NUMBER	NAME	AREA
100	VESTIBULE	257 SF
101	EXHIBIT SPACE	3798 SF
200	MEZZANINE LEVEL	1482 SF
201	PASSAGE	170 SF
202	OBSERVATION DECK A	940 SF
203	OBSERVATION DECK B	601 SF
TOTAL AREA		7247 SF
TOTAL AREA:		7247 FT ²
OCCUPANT LOAD FACTOR: (ASSEMBLY, EXHIBIT GALLERY AND MUSEUM)		30 FT ² / PERSON
MAXIMUM OCCUPANCY:		241 PERSONS
REQUIRED PLUMBING FIXTURES:		
	MEN:	1 TOILET, 1 LAVATORY
	WOMEN:	2 TOILETS, 1 LAVATORY
	GENERAL:	1 WATER FOUNTAIN

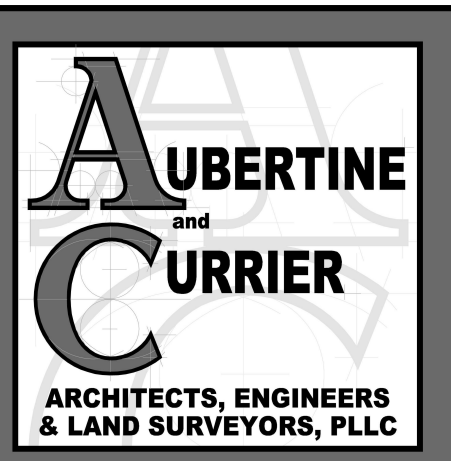


522 Bradley Street
Watertown, New York 13601

aubertinecurrier.com

Phone: (315)782-2005
Fax: (315)782-1472

The above Architect, Engineer or Land Surveyor states that to the best of his or her knowledge, information and belief, the plans and specifications are in accordance with applicable requirements of New York State. It is a violation of New York State Law for any person, unless acting under the direct supervision of a Registered Architect, Licensed Professional Engineer or Licensed Land Surveyor to alter this document in any way. If altered, such licensee shall affix his or her seal and the notification "altered by" followed by his or signature, date and a specific description of the alteration.
© COPYRIGHT 2022
AUBERTINE and CURRIER ARCHITECTS, ENGINEERS & LAND SURVEYORS, PLLC

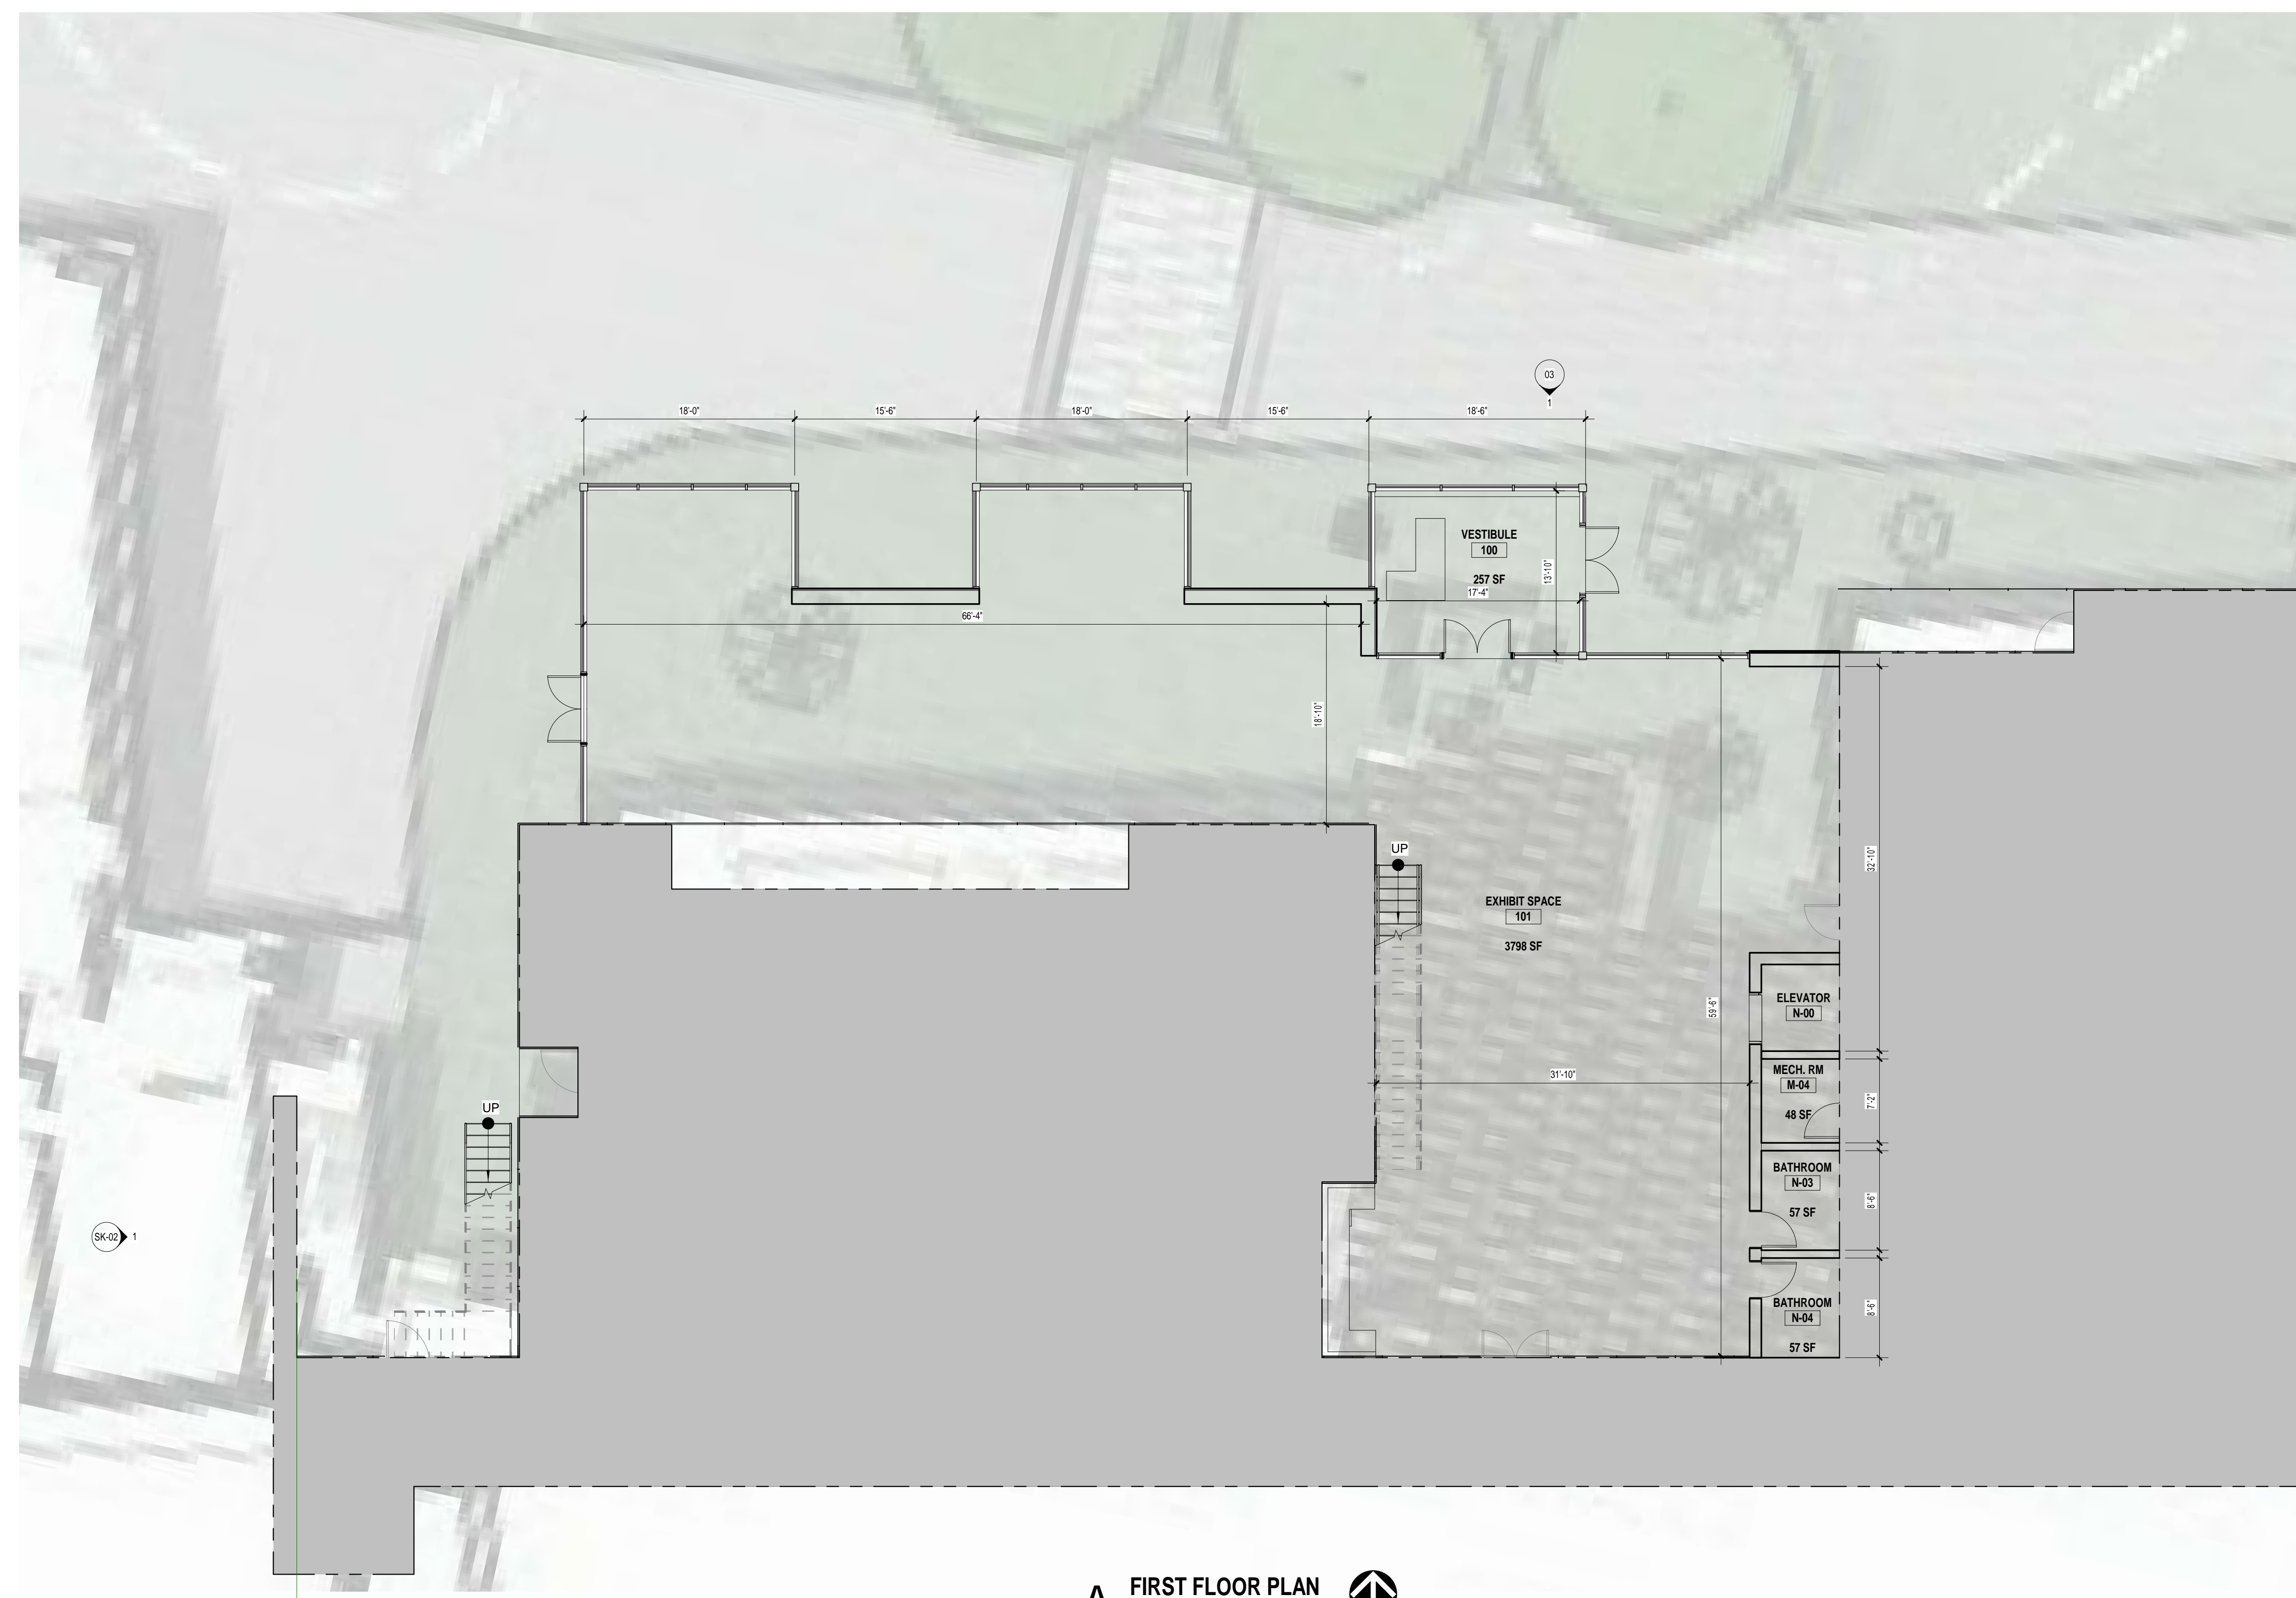

A FIRST FLOOR PLAN
1/8" = 1'-0"
PLAN NORTH


PLATTSBURGH WRRF WEST SIDE CONCEPT

PROJECT NO:	2018-100.001
SCALE:	1/8" = 1'-0"
DRAWN BY:	NPL
CHECKED BY:	BAJ
ISSUE DATES:	2022-07-21

FIRST FLOOR PLAN

01


PROGRESS PRINT - NOT FOR CONSTRUCTION

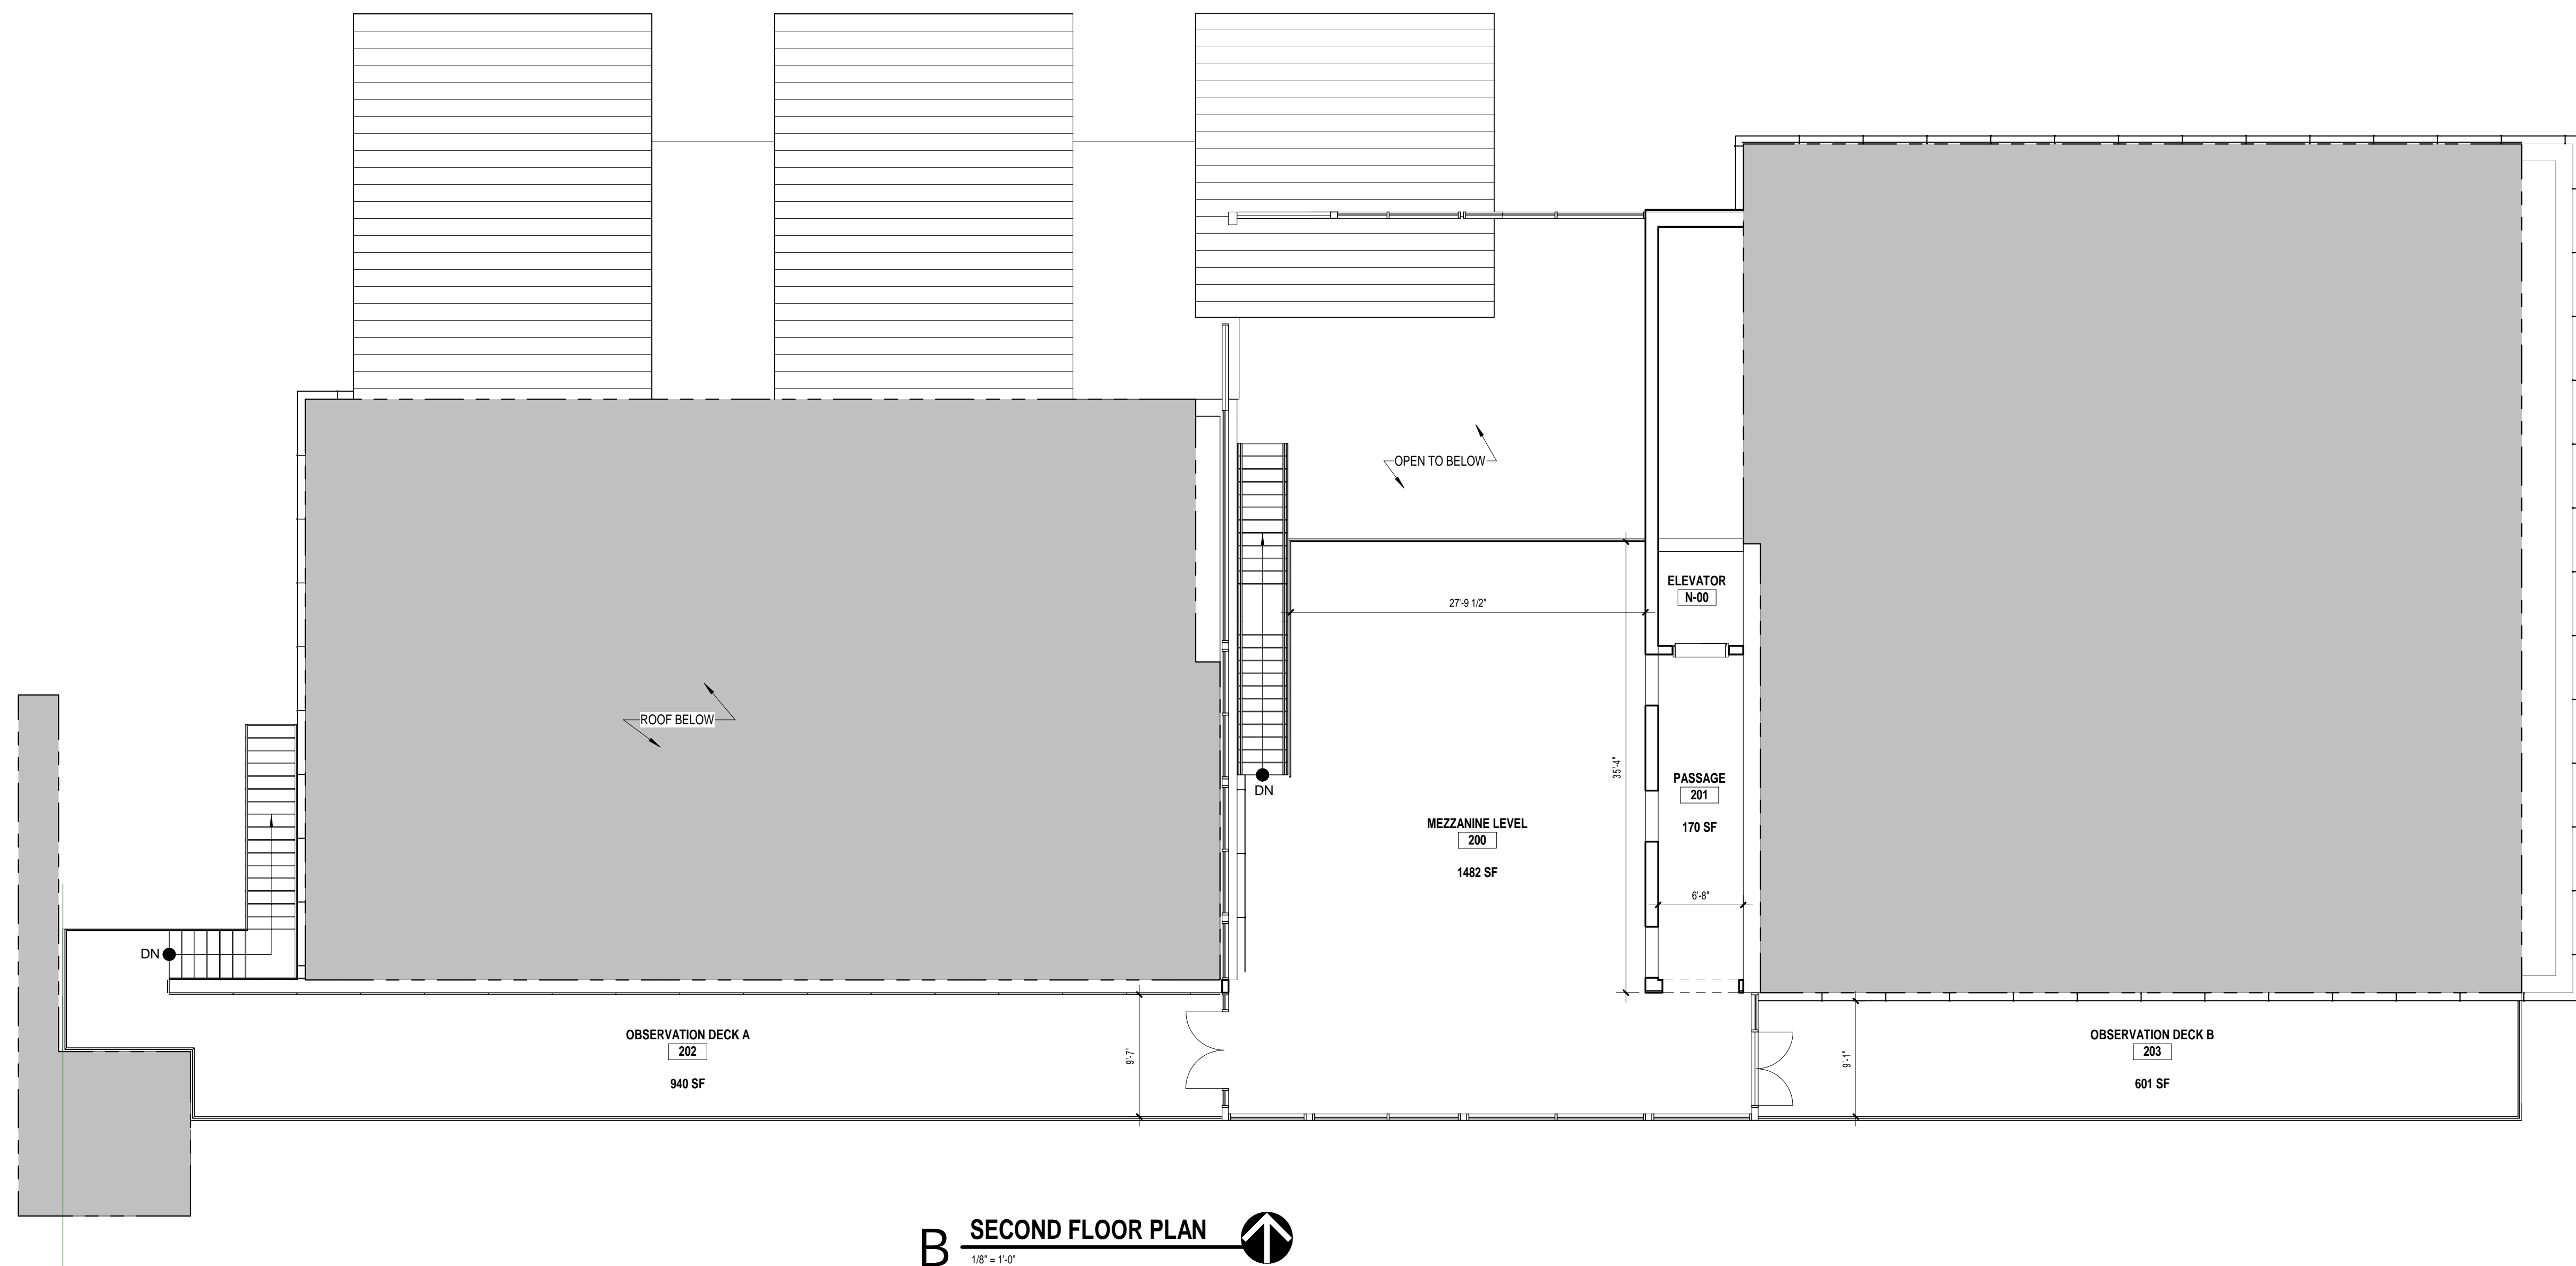

PLATTSBURGH WRRF WEST SIDE CONCEPT

PROJECT NO:	2018-100.001
SCALE:	1/8" = 1'-0"
DRAWN BY:	NPL
CHECKED BY:	BAJ
ISSUE DATES:	2022-07-21

MEZZANINE FLOOR PLAN

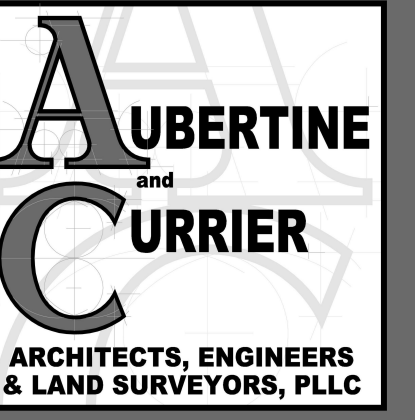

522 Bradley Street
Watertown, New York 13601

aubertinecurrier.com

Phone: (315)782-2005
Fax: (315)782-1472

The above Architect, Engineer or Land Surveyor states that to the best of his or her knowledge, information and belief, the plans and specifications are in accordance with applicable requirements of New York State. It is a violation of New York State Law for any person, unless acting under the direct supervision of a Registered Architect, Licensed Professional Engineer or Licensed Land Surveyor to alter this document in any way. If altered, such licensee shall affix his or her seal and the notification "altered by" followed by his or signature, date and a specific description of the alteration.

© COPYRIGHT 2022
AUBERTINE and CURRIER ARCHITECTS, ENGINEERS & LAND SURVEYORS, PLLC




WEST ELEVATION


PLATTSBURGH WRRF WEST SIDE CONCEPT

PROJECT NO: 2018-100.001
SCALE: 3/16" = 1'-0"
DRAWN BY: NPL
CHECKED BY: BAJ
ISSUE DATES:
2022-07-21


BUILDING ELEVATIONS

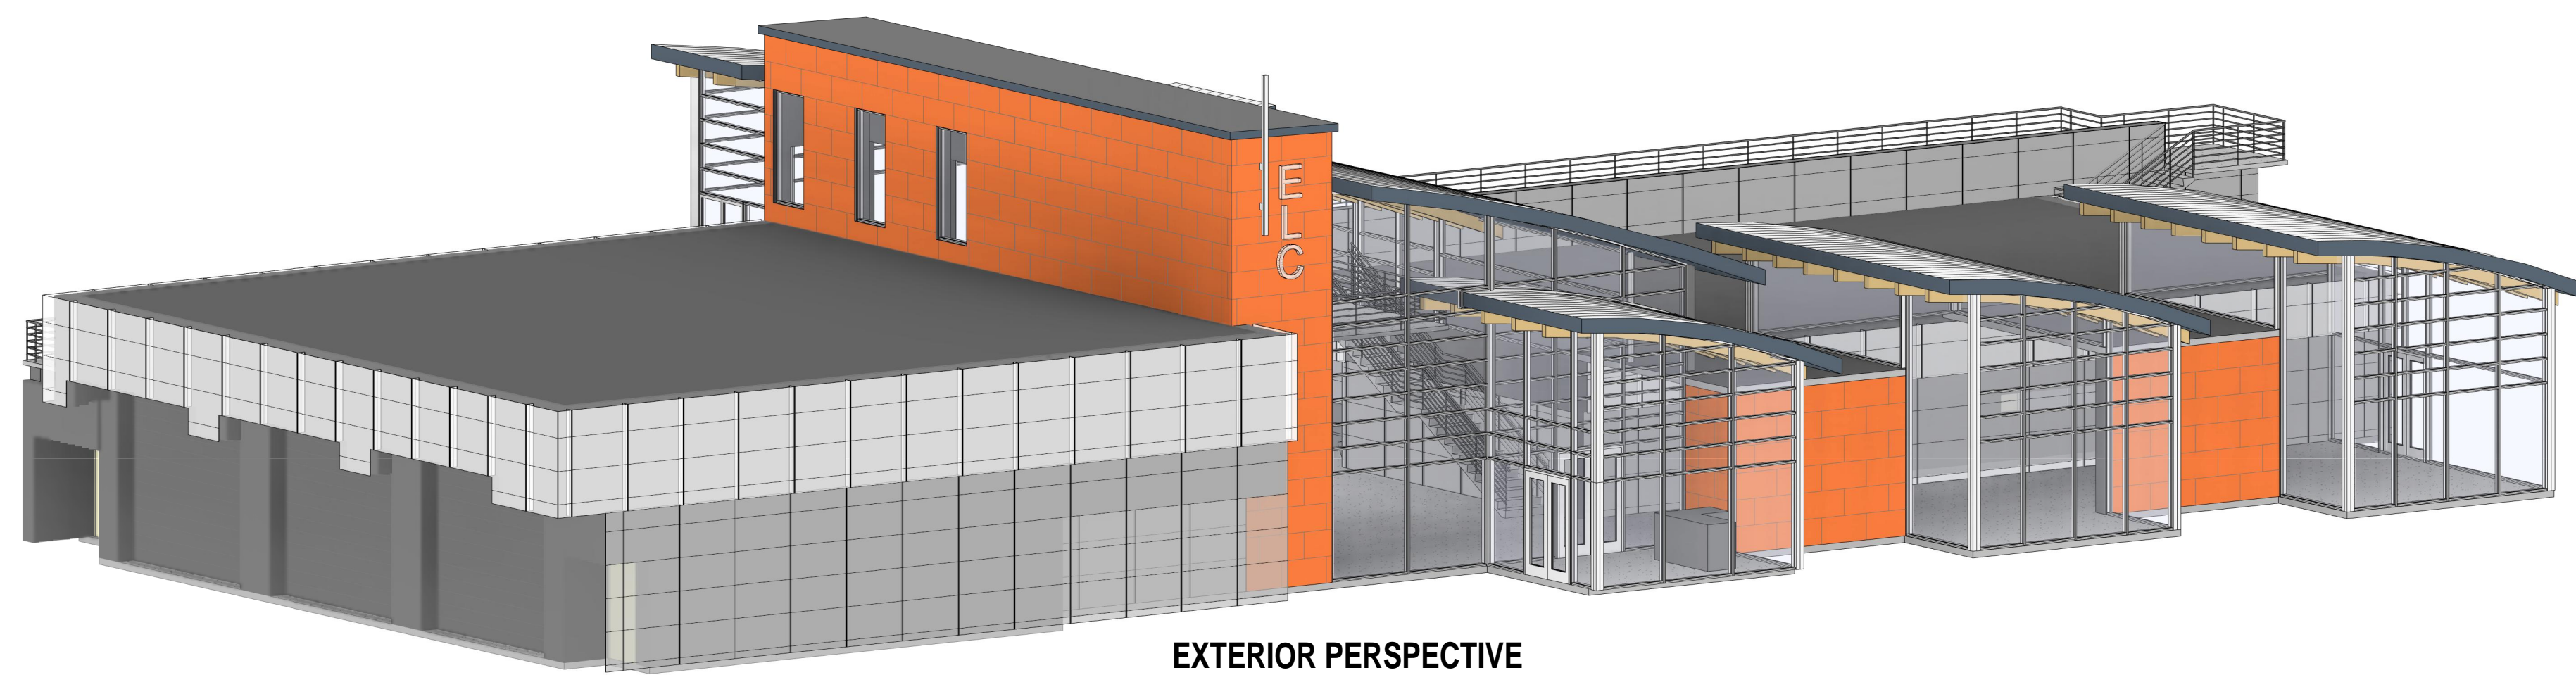


EXTERIOR PERSPECTIVE

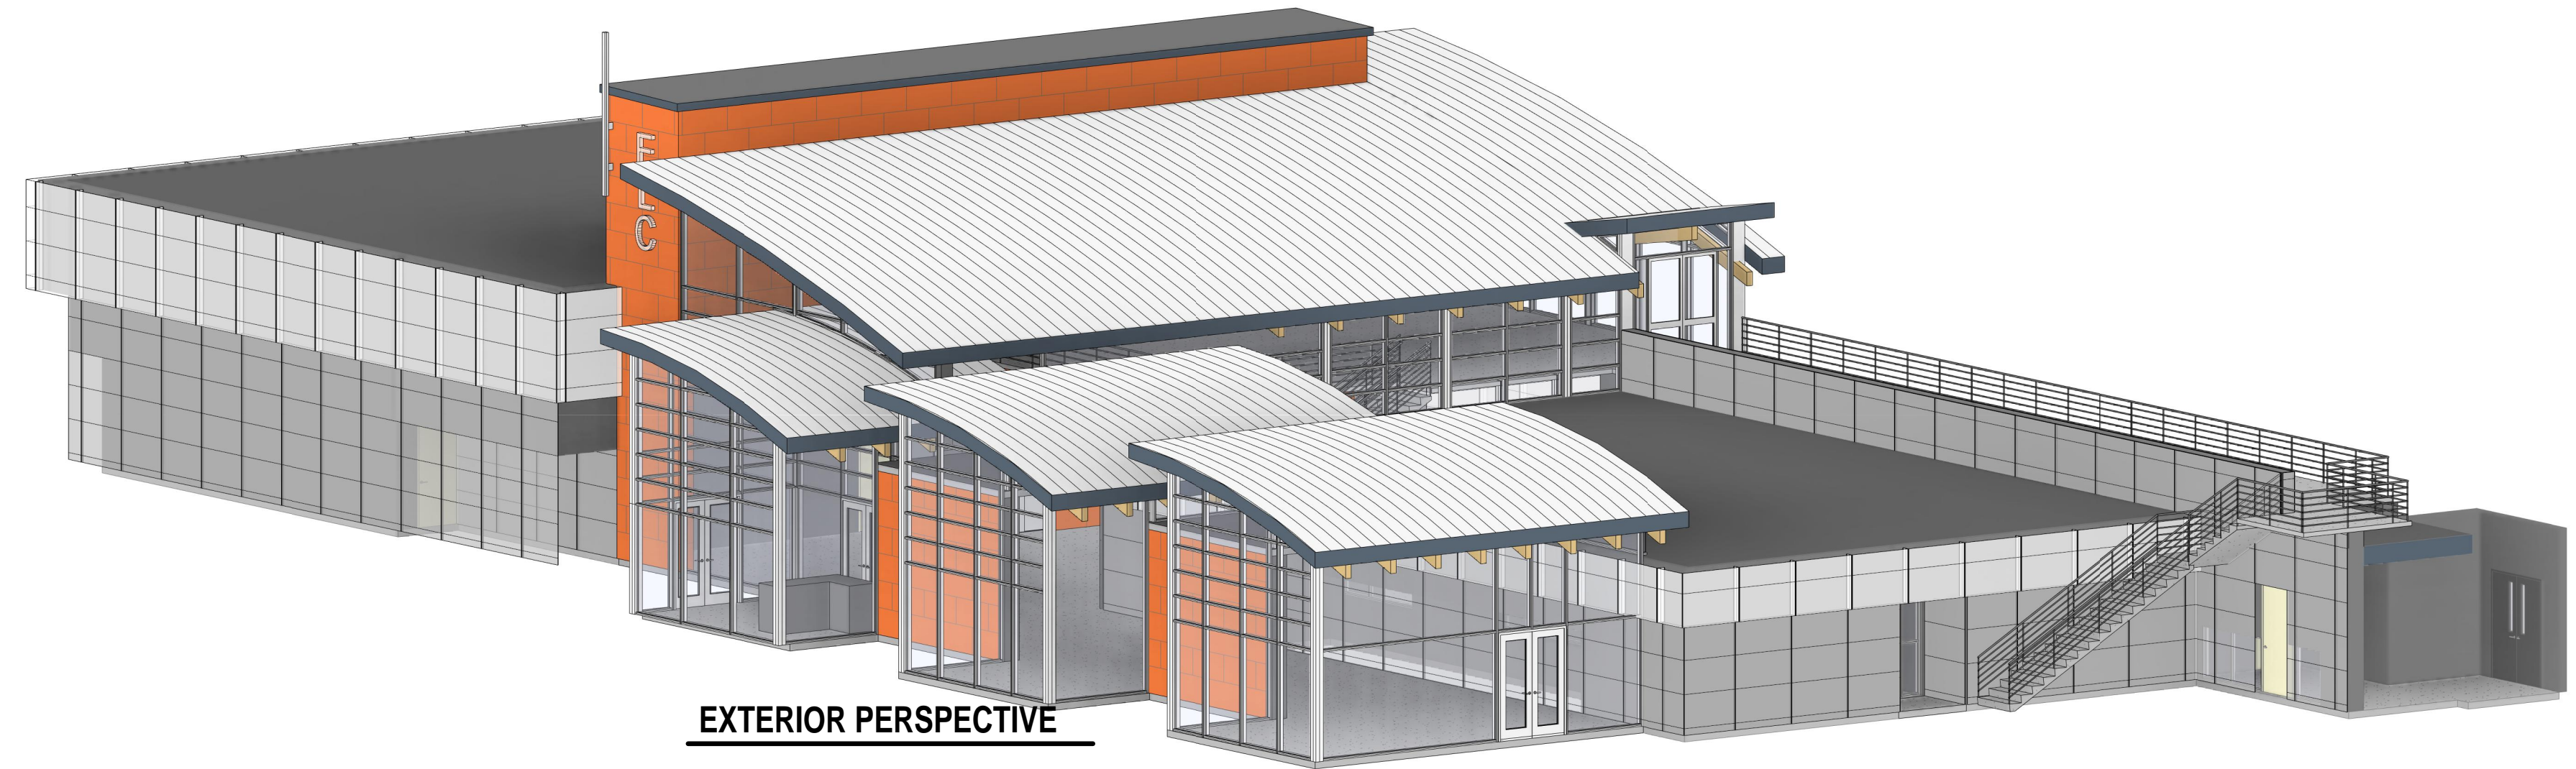

EXTERIOR PERSPECTIVE

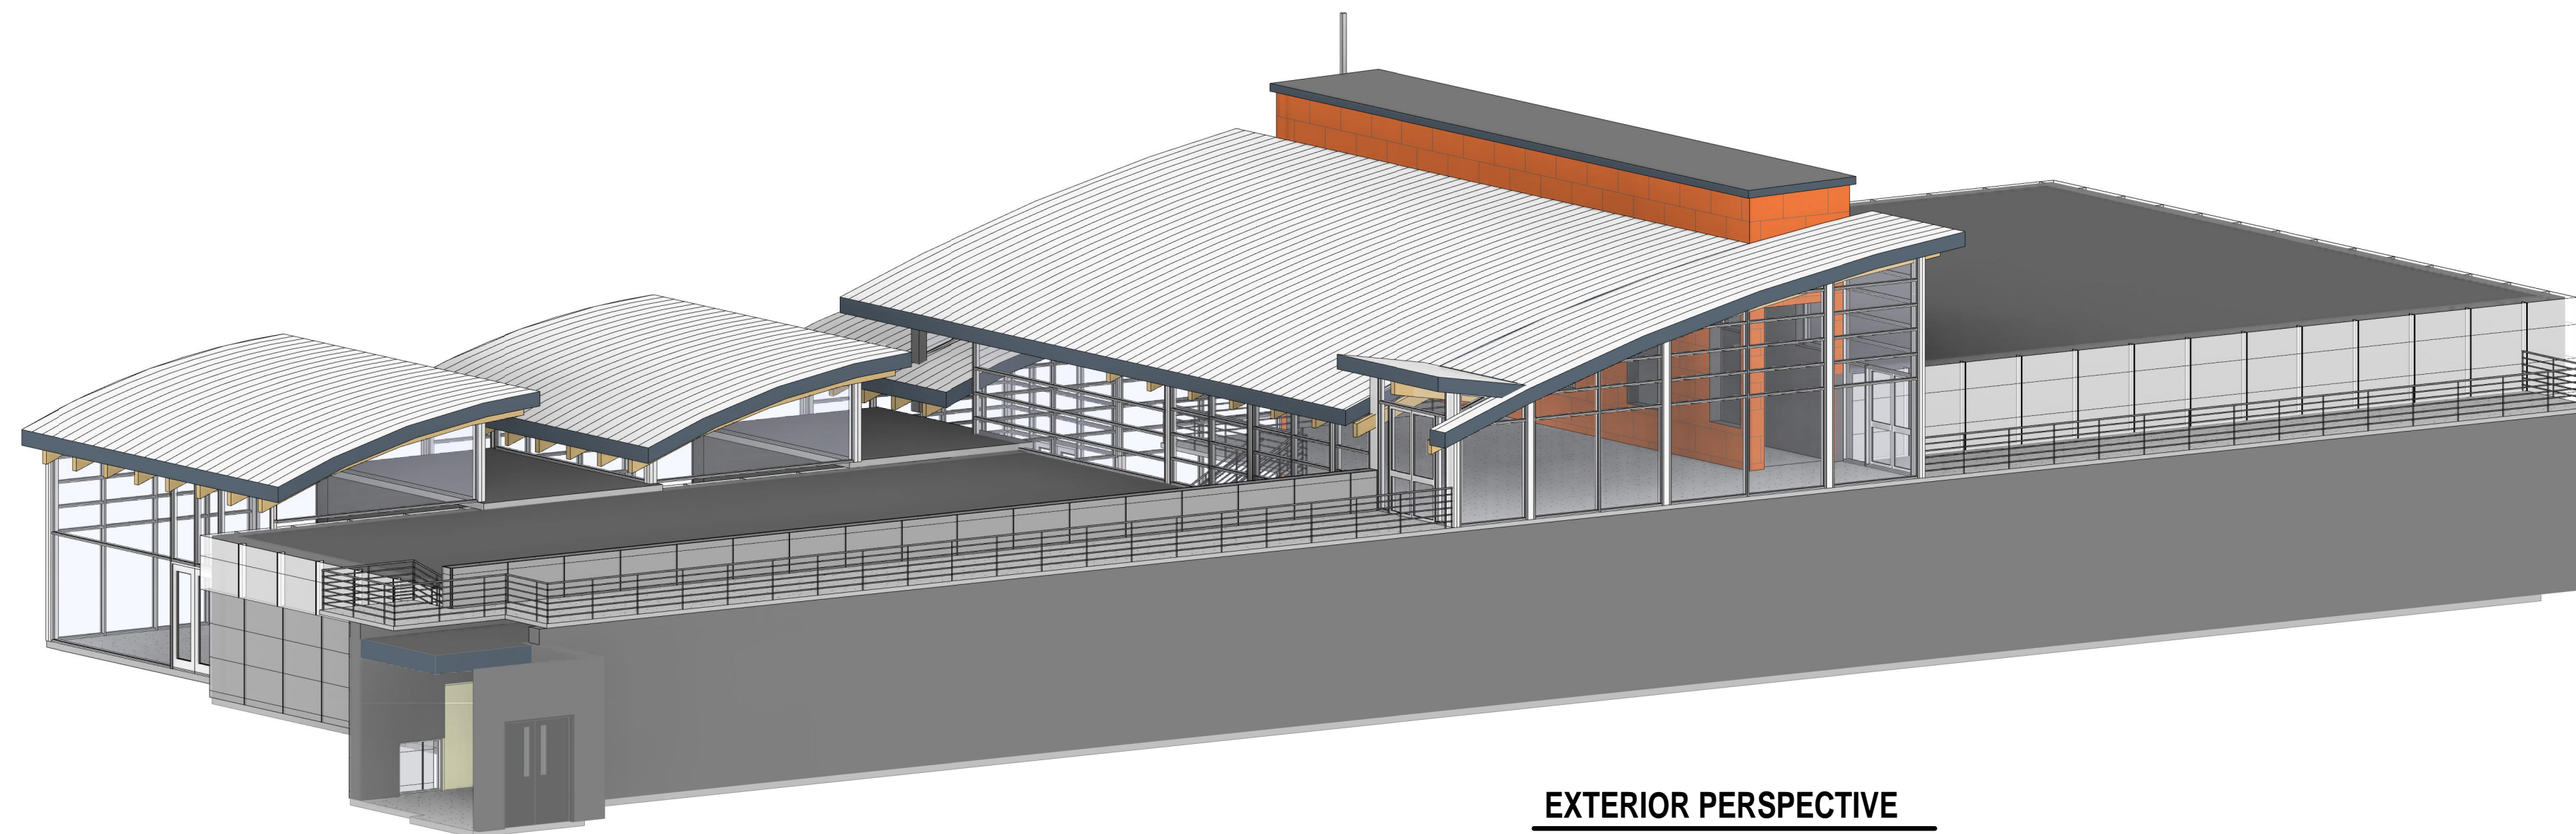

EXTERIOR PERSPECTIVE

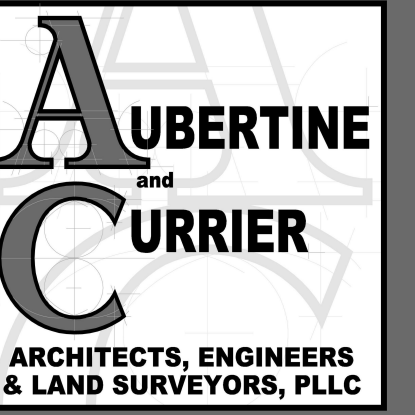

522 Bradley Street
Watertown, New York 13601

aubertinecurrier.com

Phone: (315)782-2005
Fax: (315)782-1472

The above Architect, Engineer or Land Surveyor states that to the best of his or her knowledge, information and belief, the plans and specifications are in accordance with applicable requirements of New York State. It is a violation of New York State Law for any person, unless acting under the direct supervision of a Registered Architect, Licensed Professional Engineer or Licensed Land Surveyor to alter this document in any way. If altered, such licensee shall affix his or her seal and the notification "altered by" followed by his or signature, date and a specific description of the alteration.

© COPYRIGHT 2022
AUBERTINE and CURRIER ARCHITECTS, ENGINEERS & LAND SURVEYORS, PLLC

PLATTSBURGH WRRF WEST SIDE CONCEPT

PROJECT NO: 2018-100.001

SCALE:


DRAWN BY: NPL

CHECKED BY: BAJ

ISSUE DATES:
2022-07-21

BUILDING PERSPECTIVES

04

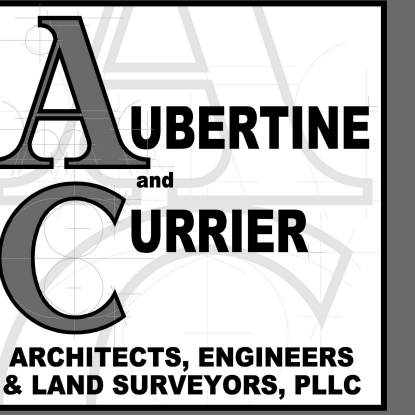

522 Bradley Street
Watertown, New York 13601

aubertinecurrier.com

Phone: (315)782-2005
Fax: (315)782-1472

The above Architect, Engineer or Land Surveyor states that to the best of his or her knowledge, information and belief, the plans and specifications are in accordance with applicable requirements of New York State. It is a violation of New York State Law for any person, unless acting under the direct supervision of a Registered Architect, Licensed Professional Engineer or Licensed Land Surveyor to alter this document in any way. If altered, such licensee shall affix his or her seal and the notification "altered by" followed by his or signature, date and a specific description of the alteration.

© COPYRIGHT 2022
AUBERTINE and CURRIER ARCHITECTS, ENGINEERS & LAND SURVEYORS, PLLC


PLATTSBURGH WRRF WEST SIDE CONCEPT

PROJECT NO: 2018-100.001
SCALE:
DRAWN BY: NPL
CHECKED BY: BAJ
ISSUE DATES:
2022-07-21

EXTERIOR RENDERING

05

PROGRESS PRINT - NOT FOR CONSTRUCTION

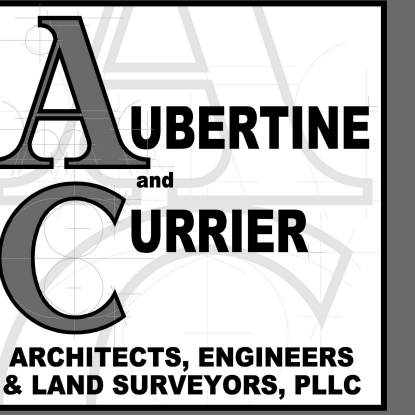

522 Bradley Street
Watertown, New York 13601

aubertinecurrier.com

Phone: (315)782-2005
Fax: (315)782-1472


The above Architect, Engineer or Land Surveyor states that to the best of his or her knowledge, information and belief, the plans and specifications are in accordance with applicable requirements of New York State. It is a violation of New York State Law for any person, unless acting under the direct supervision of a Registered Architect, Licensed Professional Engineer or Licensed Land Surveyor to alter this document in any way. If altered, such licensee shall affix his or her seal and the notification "altered by" followed by his or signature, date and a specific description of the alteration.

© COPYRIGHT 2022
AUBERTINE and CURRIER ARCHITECTS, ENGINEERS & LAND SURVEYORS, PLLC

PLATTSBURGH WRRF WEST SIDE CONCEPT

PROJECT NO: 2018-100.001
SCALE:
DRAWN BY: NPL
CHECKED BY: BAJ
ISSUE DATES:
2022-07-21

EXTERIOR RENDERING

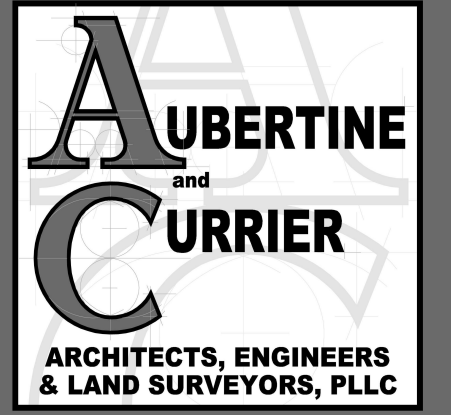


522 Bradley Street
Watertown, New York 13601

aubertinecurrier.com

Phone: (315)782-2005
Fax: (315)782-1472

The above Architect, Engineer or Land Surveyor states that to the best of his or her knowledge, information and belief, the plans and specifications are in accordance with applicable requirements of New York State. It is a violation of New York State Law for any person, unless acting under the direct supervision of a Registered Architect, Licensed Professional Engineer or Licensed Land Surveyor to alter this document in any way. If altered, such licensee shall affix his or her seal and the notification "altered by" followed by his or signature, date and a specific description of the alteration.

© COPYRIGHT 2022
AUBERTINE and CURRIER ARCHITECTS, ENGINEERS & LAND SURVEYORS, PLLC

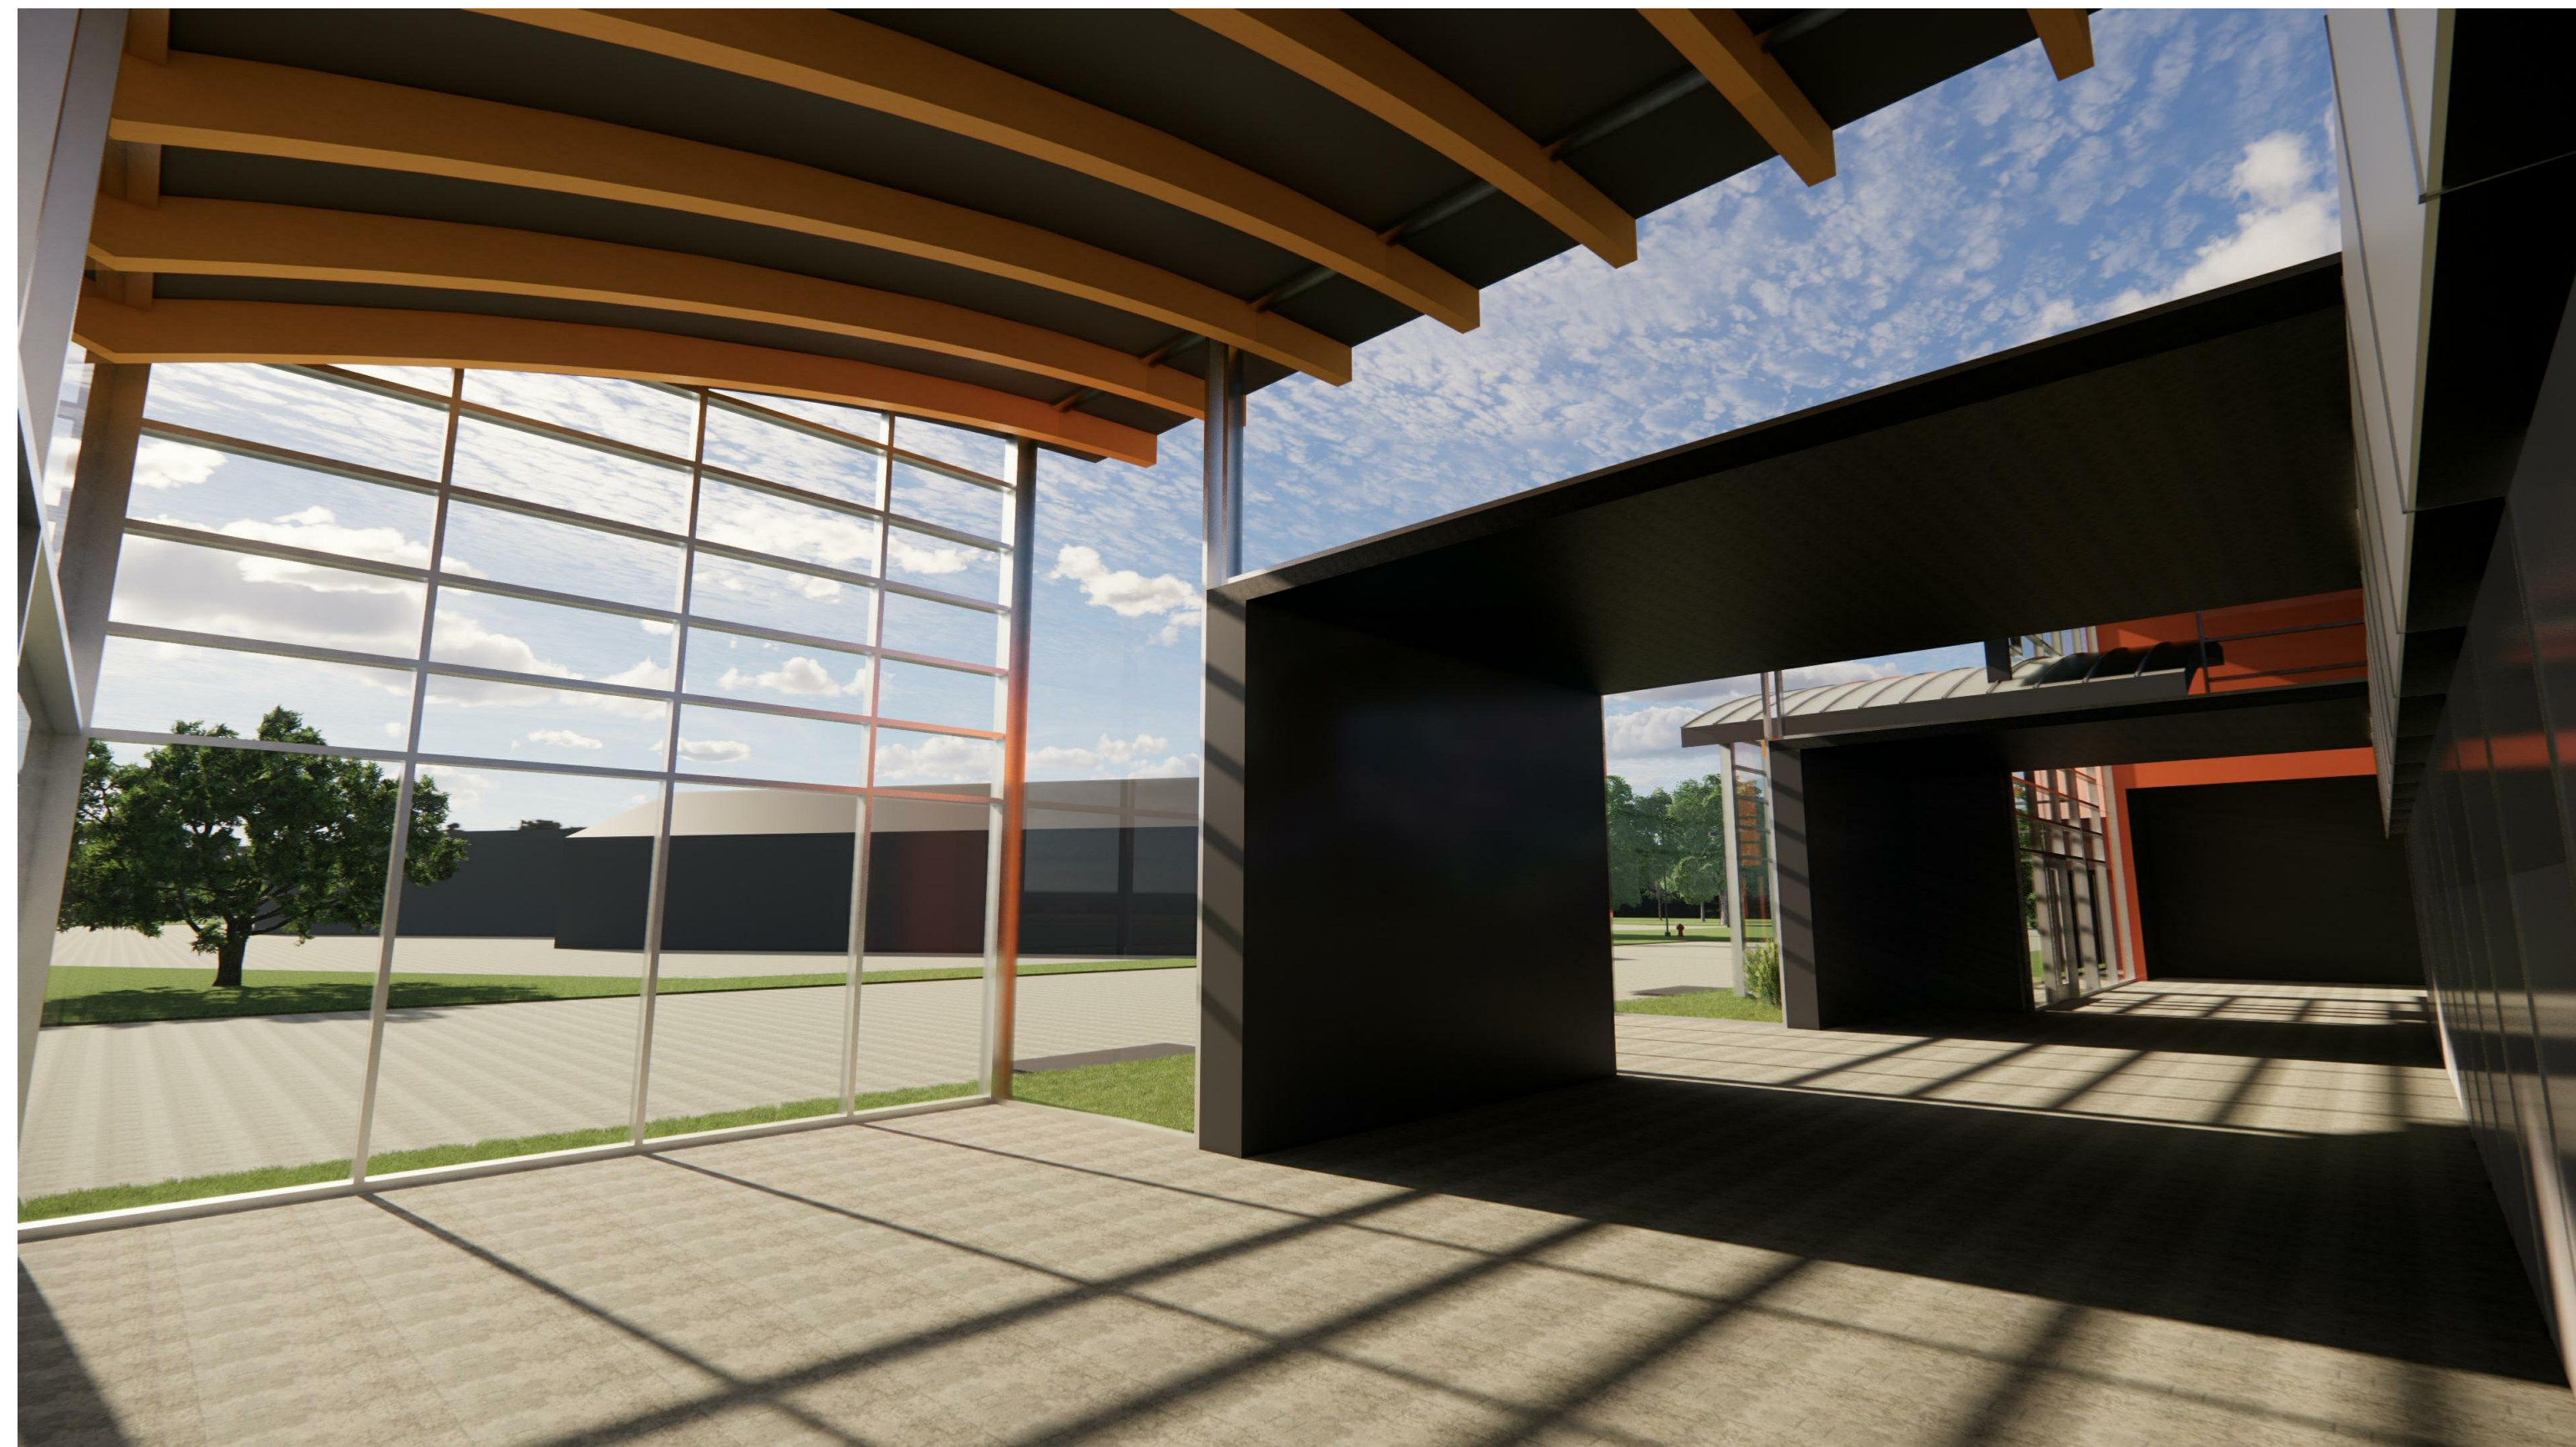

PLATTSBURGH WRRF WEST SIDE CONCEPT

PROJECT NO: 2018-100.001
SCALE:
DRAWN BY: NPL
CHECKED BY: BAJ
ISSUE DATES:
2022-07-21

INTERIOR PERSPECTIVES